


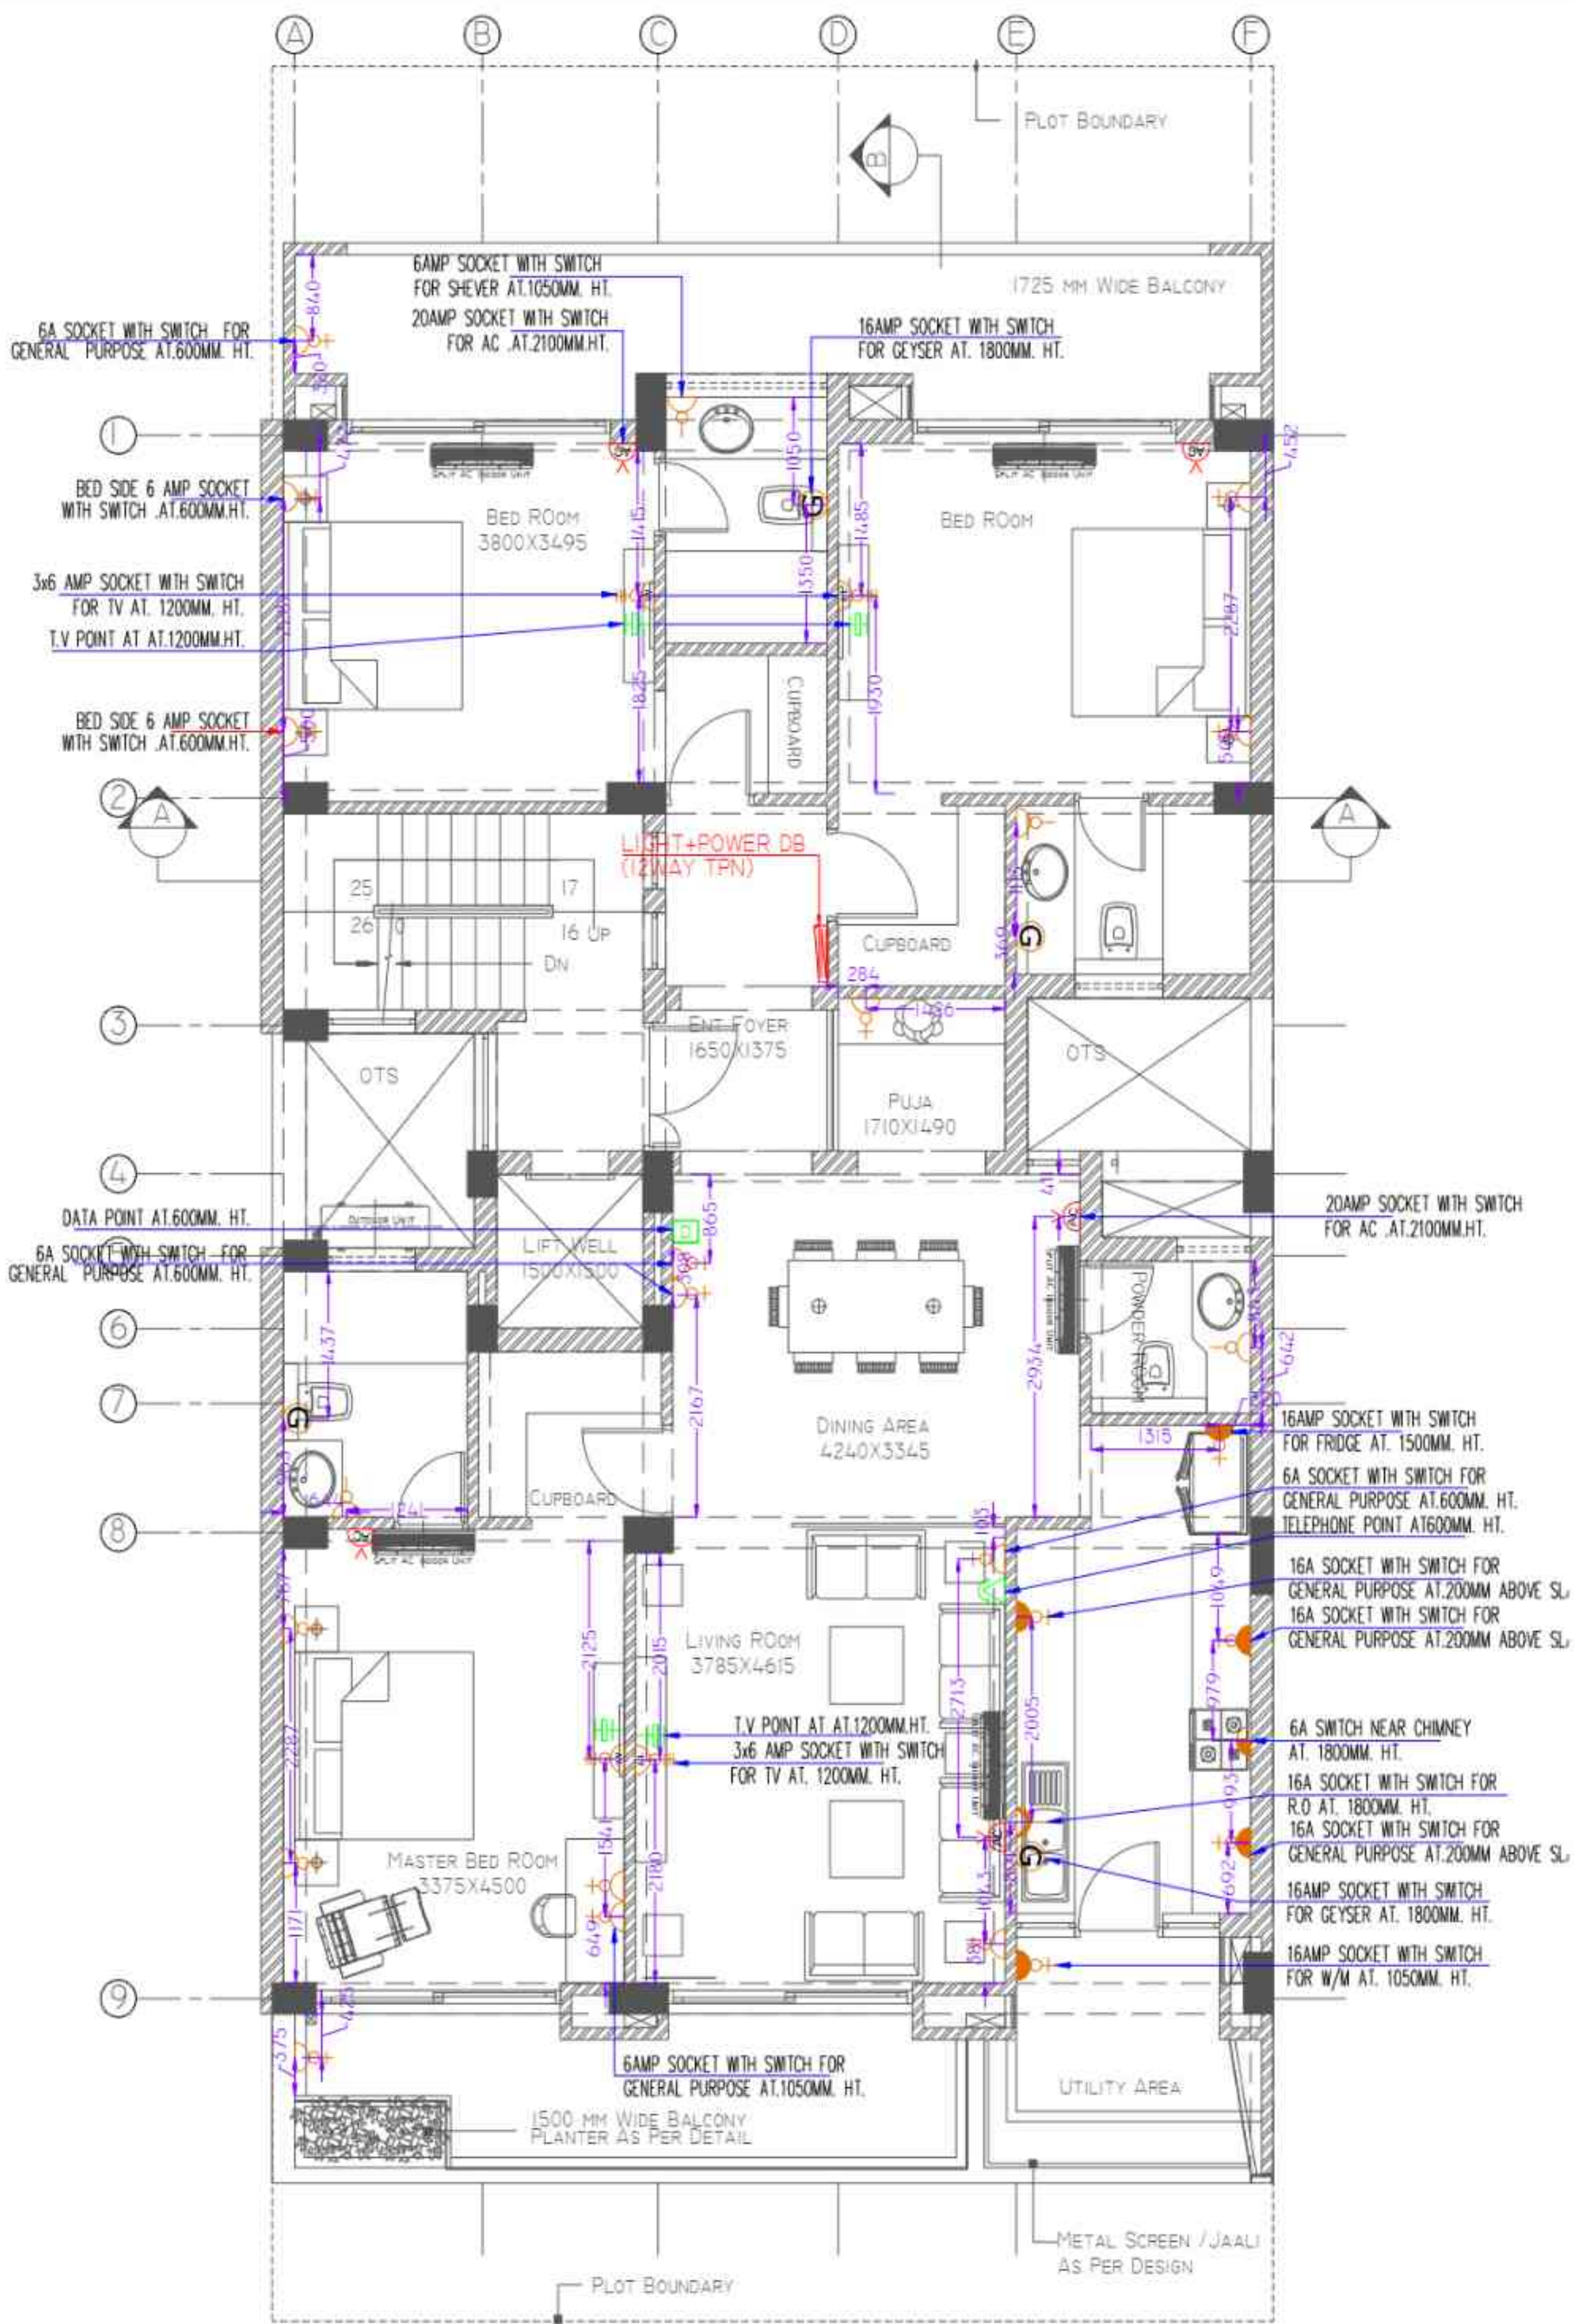

FIRST FLOOR PLAN

POWER & L.V. LEGEND:-

S.NO.	SYMBOL	DESCRIPTION	HEIGHT	QTY.
01.		6A ROUND PIN SOCKET & 6A SWITCH NEAR EXHAUST FAN	2250MM FFL	05
02.		6A ROUND PIN SOCKET & 6A SWITCH NEAR BED SIDE	650MM FFL	14
03.		3x6A ROUND PIN SOCKET & 6A SWITCH NEAR TV	1050MM FFL	04
04.		6A ROUND PIN SOCKET & 6A SWITCH IN TOILET	1050MM FFL	04
05.		6A ROUND PIN SOCKET & 6A SWITCH NEAR CHIMNEY	1850MM FFL	01
06.		6/16A ROUND PIN SOCKET & 16A SWITCH NEAR RO	1850MM FFL	01
07.		6/16A SHUTTERED PIN SOCKET & 16A SWITCH IN KITCHEN	1250MM FFL	05
08.		6/16A SHUTTERED PIN SOCKET & 16A SWITCH NEAR GEYSER	1850MM FFL	04
09.		20A SHUTTERED PIN SOCKET & 20A SWITCH NEAR INDOOR A.C	2250MM FFL	05
10.		TELEVISION OUTLET	1050MM FFL	04
11.		TELEPHONE OUTLET	650MM FFL	01
12.		DATA OUTLET	650MM FFL	01
13.		DOUBLE DOOR DISTRIBUTION BOARD	1500MM FFL	01

NOTES:-

- ALL LEVELS ARE GIVEN WITH REGARD TO C.L. OF ROAD AT ENTRANCE GATE 45.00
- DRAWINGS TO BE READ IN CONJUNCTION WITH RELEVANT CONSULTANTS' DRAWINGS.
- ANY DISCREPANCIES TO BE BROUGHT TO THE NOTICE OF THE ARCHITECT.
- DRAWINGS TO BE READ AND NOT SCALED.
- ALL DIMENSIONS & LEVELS ARE IN M.M.

CLIENT
K.N CHABRA

ARCHITECT:
RESI ARCH

MEP CONSULTANTS
APN CONSULTANT
874/B-4, Ground Floor, Deoli,
New Delhi-110082.
Cont.no.-91-9818870798
E-Mail- apnconsultant21@gmail.com.
Web-www.apnconsultant.com

REVISIONS

NO.	DATE	DESCRIPTION

DRAWN
SANJEEV

CHECKED BY
ARVIND

STATUS
APPROVAL

PROJECT
PLOT NO.- B 1305, PALAM VIHAR GURGAON

SHEET TITLE
ELECTRICAL TYPICAL POWER POINT DETAIL LAYOUT

SCALE
1:75@A3

DATE
09.07.21

SHEET SIZE
A3

DRAWING NO.
EL/RESI/07

REVISION NO.
R3

