


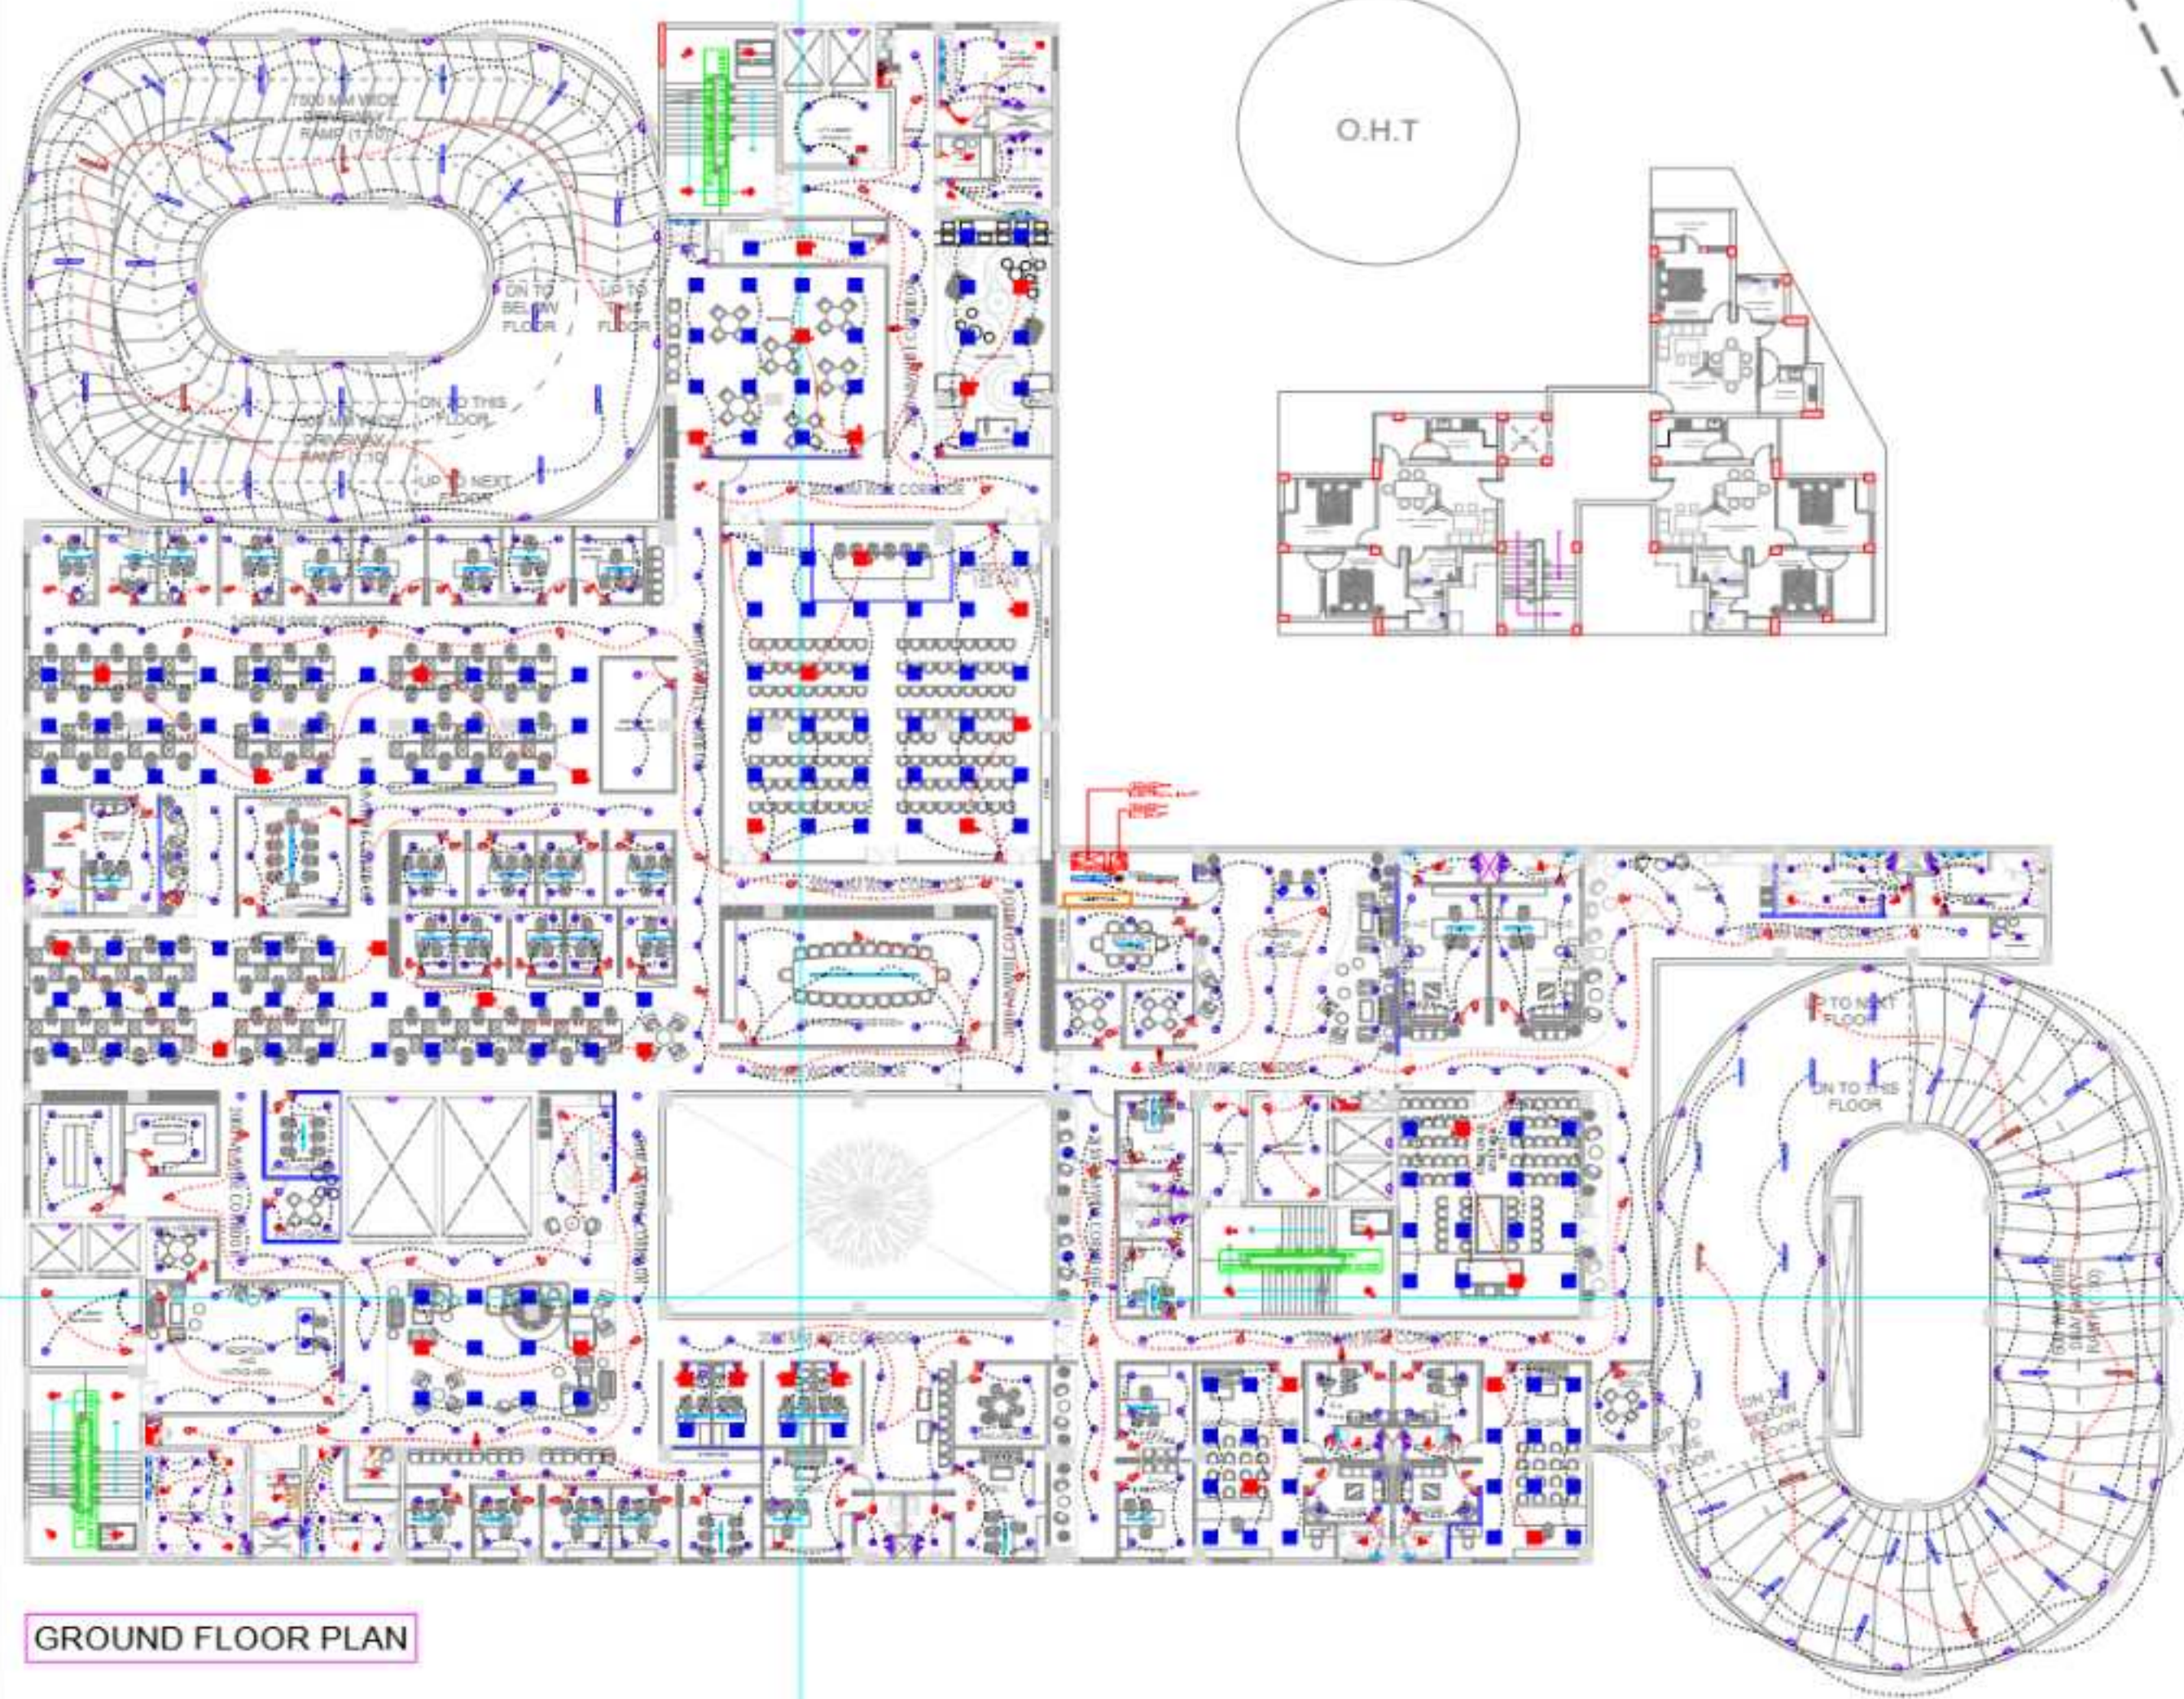

GROUND FLOOR PLAN

GROUND FLOOR LEGENDS:-LIGHTING SYSTEM

ELECTRICAL - LIGHTING			
SYMBOL	DESCRIPTION	QTY	HEIGHT
	SWITCH BOARD	00	
	10W LED MIRROR LIGHT (TOILET)	25	
	12W SURFACE MOUNTED LED DOWNLIGHTER (TOILET)	61	
	15W SURFACE MOUNTED LED DOWNLIGHTER (STAIRCASE)	12	
	18W SURFACE MOUNTED LED DOWNLIGHTER (COMMON AREA)	440	
	20W SURFACE MOUNTED LED TUBELIGHT	65	
	LINEAR CHANNEL LIGHT	44	
	DESIGNER LIGHT	06	
	70W LED STREET LIGHT 7.5M. POLE MOUNTED	00	
	70W LED STREET LIGHT 7.5M. POLE MOUNTED	00	
	36W (2'x2') GRID LIGHT	189	
	BULK HEAD LIGHT	56	
	EXHAUST FAN	16	
	CEILING ROSE	16	

REVISION	
1	ISSUED FOR PERMIT ARCHITECTURE
2	ISSUED FOR PERMIT DRAWING
3	ISSUED FOR PERMIT PLANNING
4	DATE
5	DESCRIPTION
CLIENT	
HUSBORNE - GERRARD	
DEVELOPMENT AUTHORITY (M.D.A.)	
DESIGN CONSULTANT	
GROVER INFRA PVT. LTD.	
ELECTRICAL CONSULTANT:	
REGISTERED ADDRESS 101, 102, 103, 999, 1000	
PROJECT	
MULTI-LEVEL CAR PARKING AT	
RISHIKESH, UTTARANCHAL	
DRAWING TITLE	
MLCP - GROUND FLOOR PLAN	
EL - LIGHTING SYSTEM LAYOUT	
APPROVED BY	CHECKED BY
ARVIND	SANJEEV
DRAWN BY	
ANIKET	
ELECTRICAL DRAWING	
DRAWING NO. -	
APN/MLCP/GROUND LIGHTING-01	
DATE	10-04-2024
SCALE	1:1