


15 M. WIDE ROAD AS/ SITE

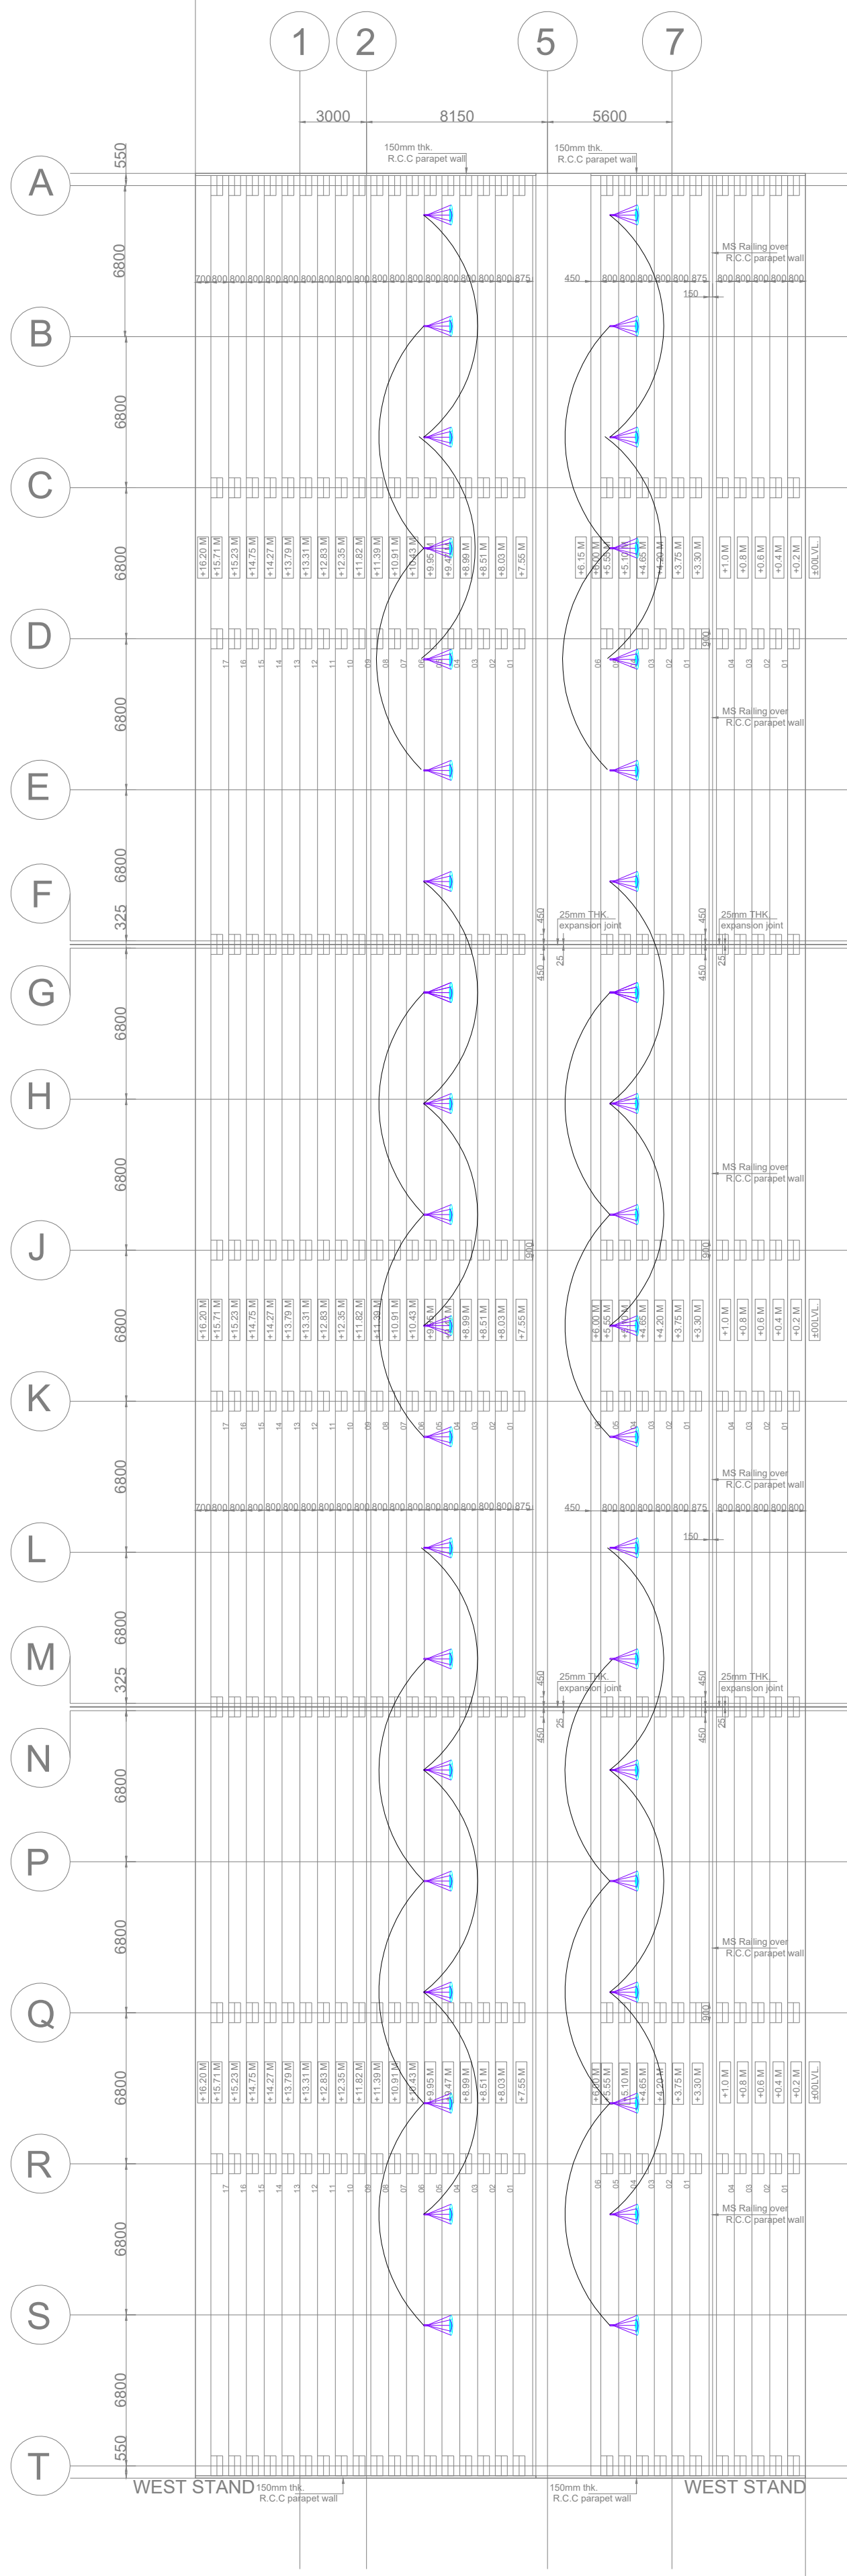

Existing Fencing
(7.5m. Height)

EXISTING SOUTH BUILDING

15 M. WIDE ROAD AS/ SITE

15 M. WIDE ROAD AS/ SITE

TENDER DRAWING

GENERAL NOTES:

1. ALL DIMENSIONS ARE IN mm AND LEVELS ARE IN METER UNLESS OTHERWISE SPECIFIED.
2. ALL DIMENSIONS ARE TO BE CHECKED AND CO-RELATED WITH THE RELEVANT ARCHITECTURAL, STRUCTURAL AND SERVICES DRAWINGS AND ANY AMBIGUITY, DISCREPANCY OR OMISSION SHALL BE BROUGHT IN TO NOTICE OF ARCHITECT PRIOR TO COMMENCEMENT OF EXECUTION.
3. DO NOT SCALE THE DRAWING, WRITTEN DIMENSION TO BE FOLLOWED.
4. THIS DRAWING TO BE READ IN CONJUNCTION WITH THE RELEVANT SERVICES AND STRUCTURAL DRAWINGS.

REVISIONS

DESCRIPTION	DATE

ELECTRICAL : LEGEND

S.NO.	SYM.	DESCRIPTION	QTY.
01		100W LED FLOOD LIGHT	63

FOR TENDER PURPOSE ONLY

CLIENT



SPORTS AUTHORITY OF GOA

CONSULTANT



GROWEVER INFRA PVT. LTD.
Sector-3, Rohini, Delhi-110085

MEP CONSULTANTS:



Registered Add:- 674/B-4, Ground Floor,
Deoli, New Delhi - 110062
Cont.no.+91-9818870796
E-Mail- apnconsultant21@gmail.com,
Web-www.apnconsultant.com.

PROJECT

RENOVATION WORK AND TENSILE ROOFING
WORK IN TILAK MAIDAN

SIGN & STAMP :

DRAWING TITLE :

SITE PLAN
ELECTRICAL LIGHTING LAYOUT

DWG. NO.	EL-ST-01	REV. NO.
DWG STAGE	TENDER DRAWING	R0
PROJECT NO.	00001	
SCALE	NTS	NORTH
1ST ISSUED ON	26-06-2023	
APPROVED	ARVIND ARYA	
CHECKED BY	ARVIND ARYA	
DRAWN BY	SANJEEV KUMAR	