

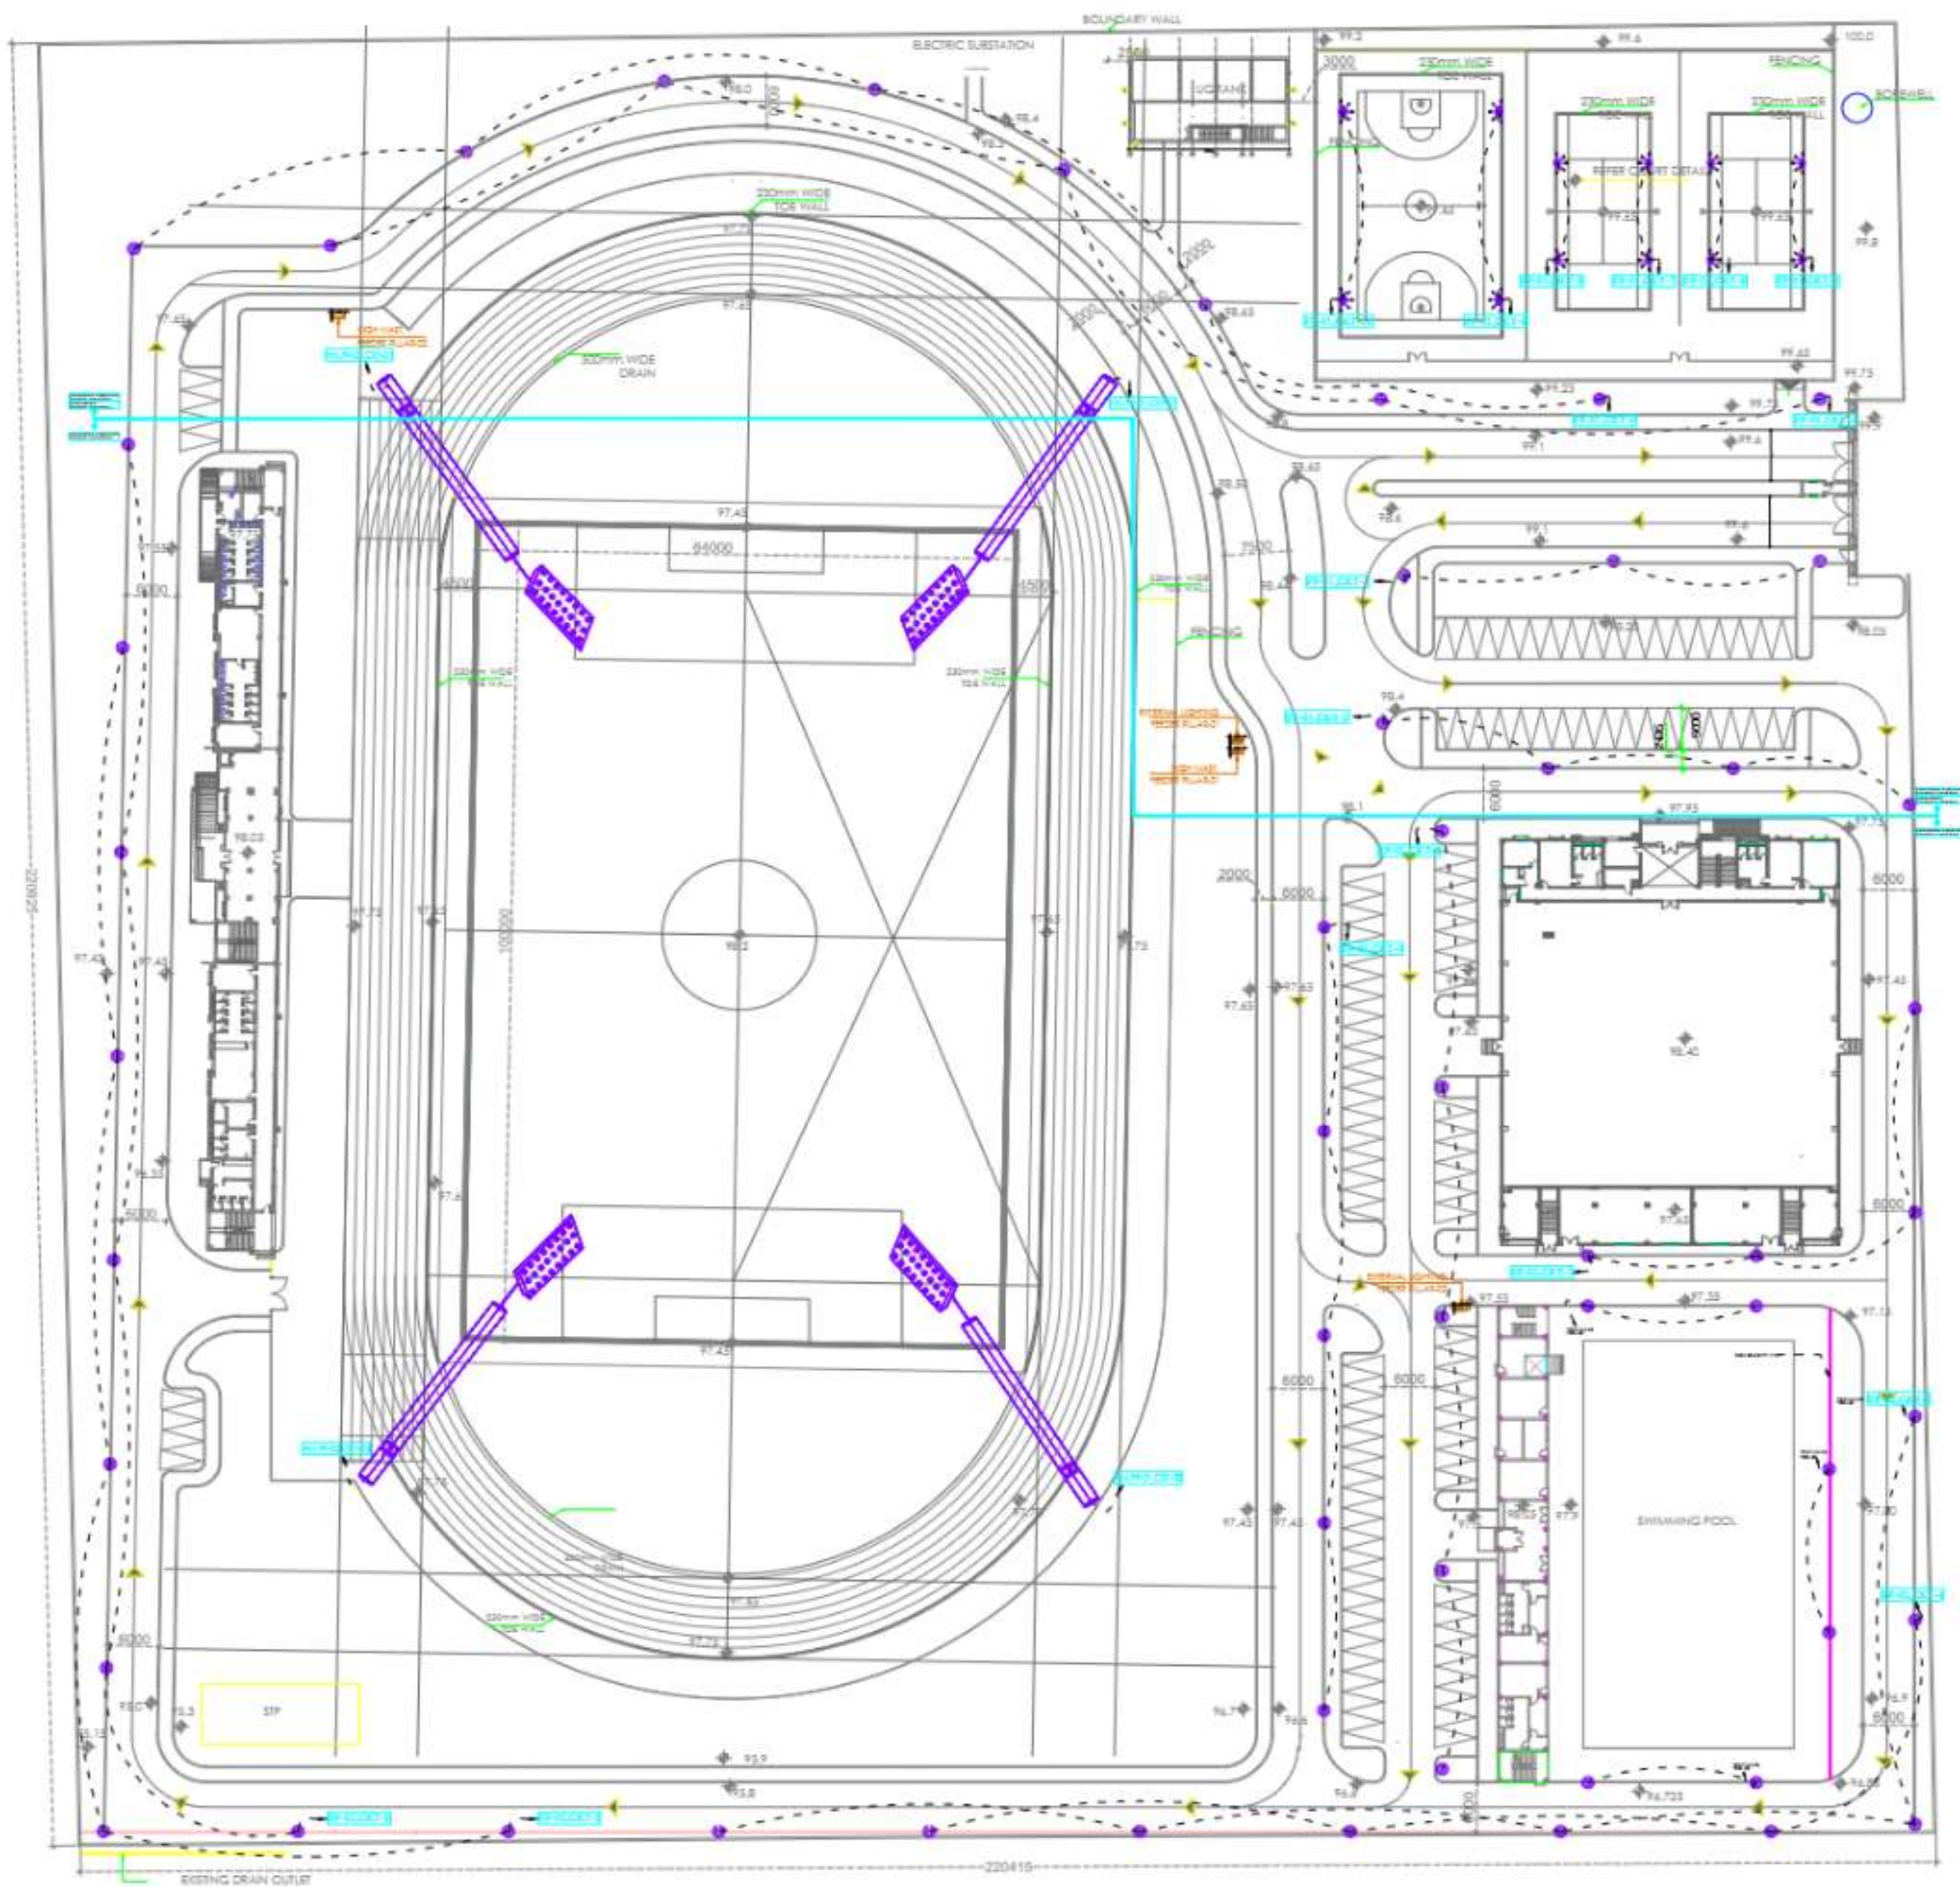


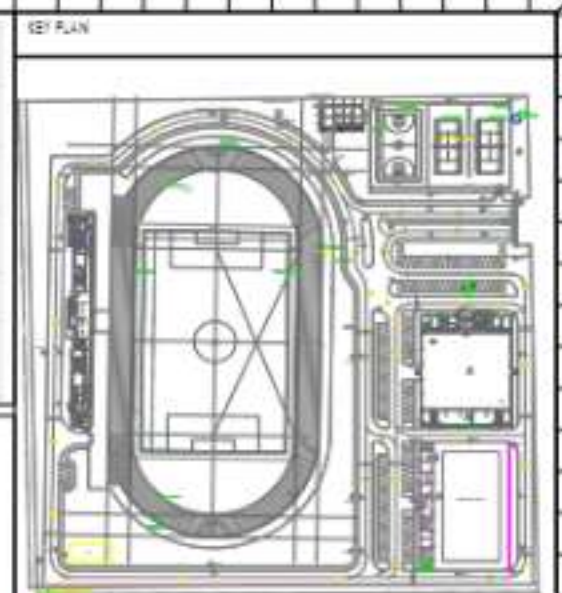

ELECTRICAL - LEGEND		QTY
	12 Mtr Single Pole with 120W LED	02
	18 Mtr Single Pole with 120W LED	04
	SINGLE ARM STREET LIGHT-40W LED	10
	PEDestal POLE (17')	
	10 METER HIGH MAST- 47w	

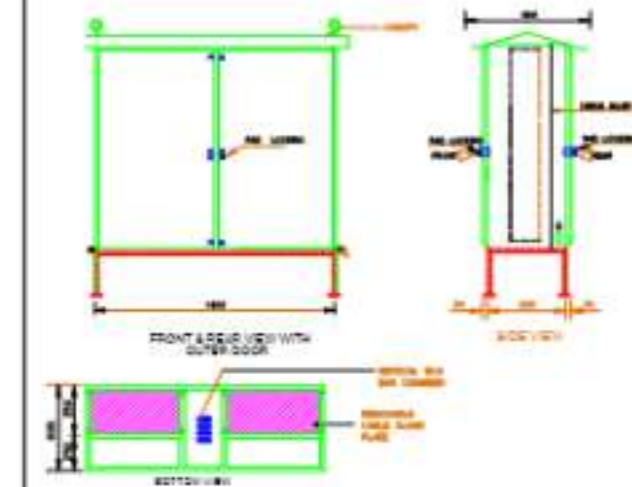

PROJECT NAME
INTEGRATED SPORTS COMPLEX, JEYPORE

PRIME CONSULTANT
WAPCOS LIMITED
(A Government of India Undertaking)

DESIGN CONSULTANT
GROWEVER INFRA PVT LTD.

MEP CONSULTANT:

G-13, BASEMENT OFFICE-04,
SECTOR-3,
NOIDA (UTTER PRADESH) -201301
Cont.no.+91-9618870796
E-Mail- apnconsultant21@gmail.com,
Web-www.apnconsultant.com

DRAWING TITLE:-
SITE PLAN
ELECTRICAL EXTERNAL LIGHTING LAYOUT

☒ FOR APPROVAL	☐ ADVANCE COPY
☐ TENDER DRAWING	☐ GOOD FOR CONSTRUCTION
DRAWN BY: SANJEV	REV NO: R0(26.05.2023)
CHK BY: ARVIND	SCALE: KTS(4:1)
PRJ. YEAR: 2022-23	JOB NO: 0008
DRAWING NO:	APN/ST/EL/EXT/LT/01-01